




1 ROOF TOP UNIT MOUNTING DETAIL
SCALE: NONE

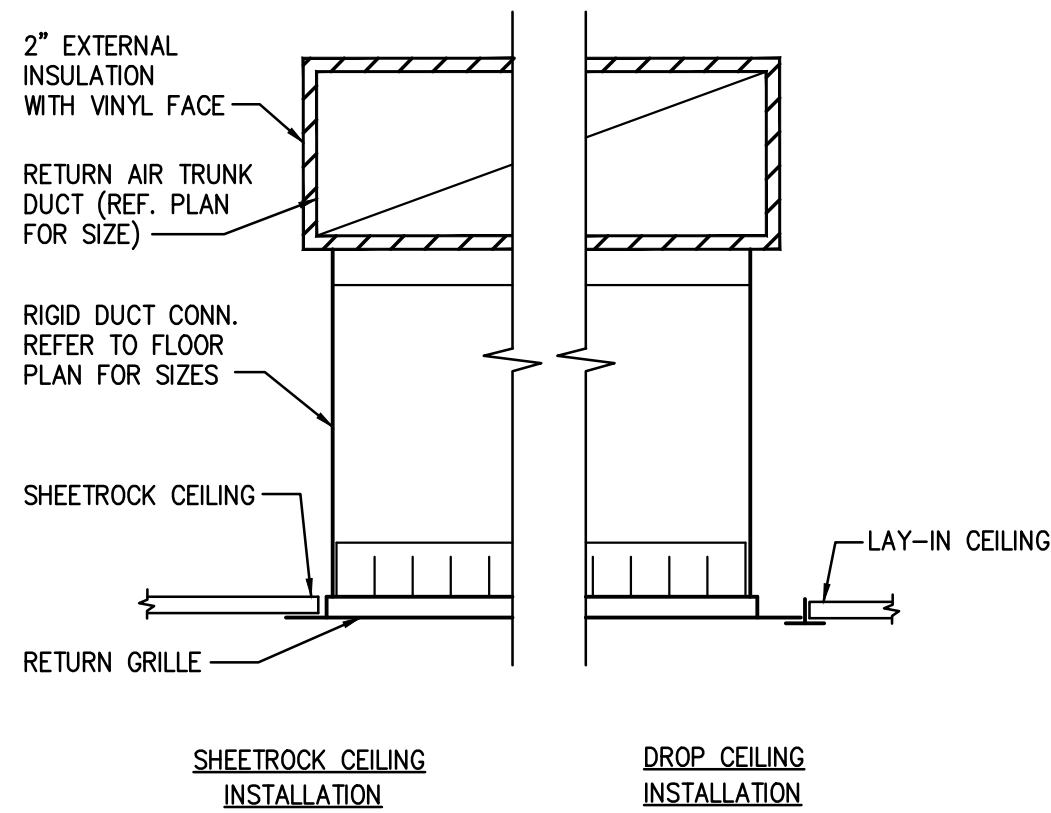


2 RETURN AIR GRILLE DETAIL
SCALE: NONE

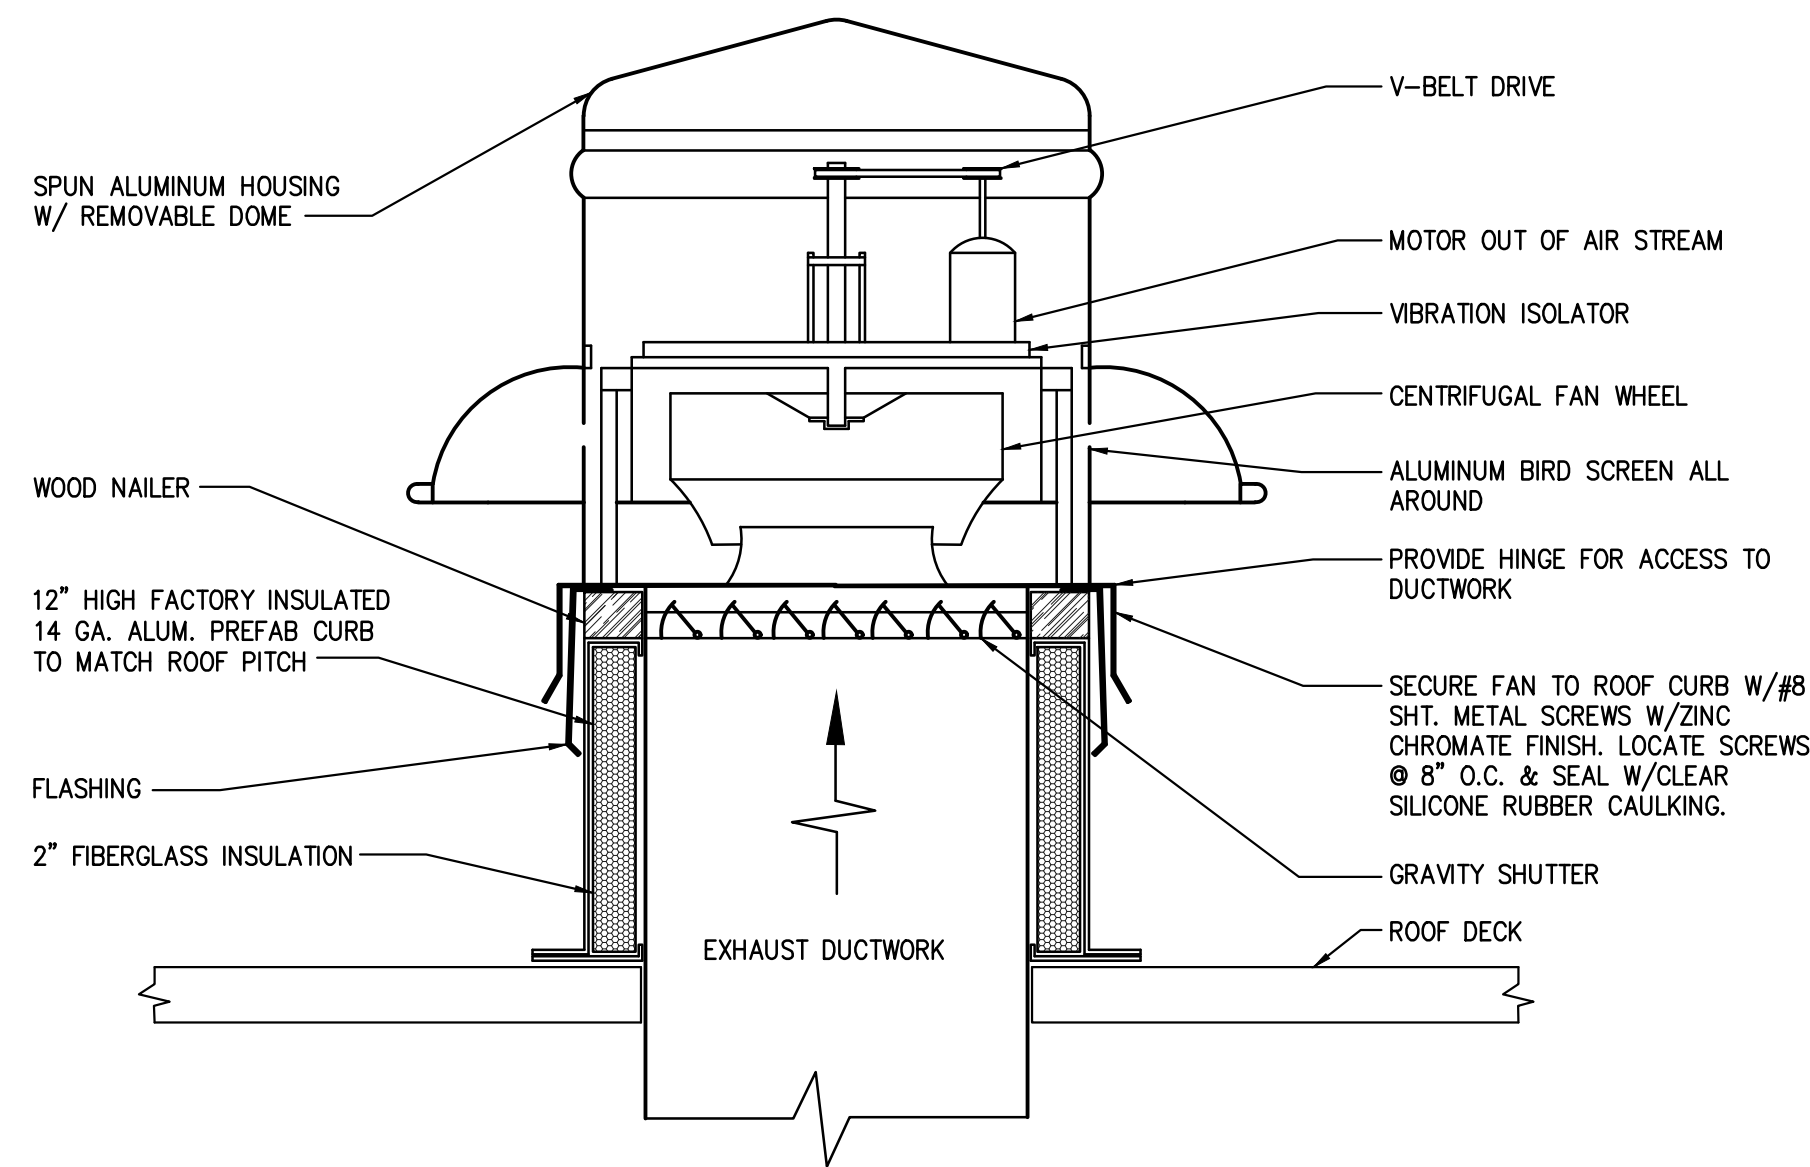

3 ROOFTOP EXHAUST FAN DETAIL
SCALE: NONE

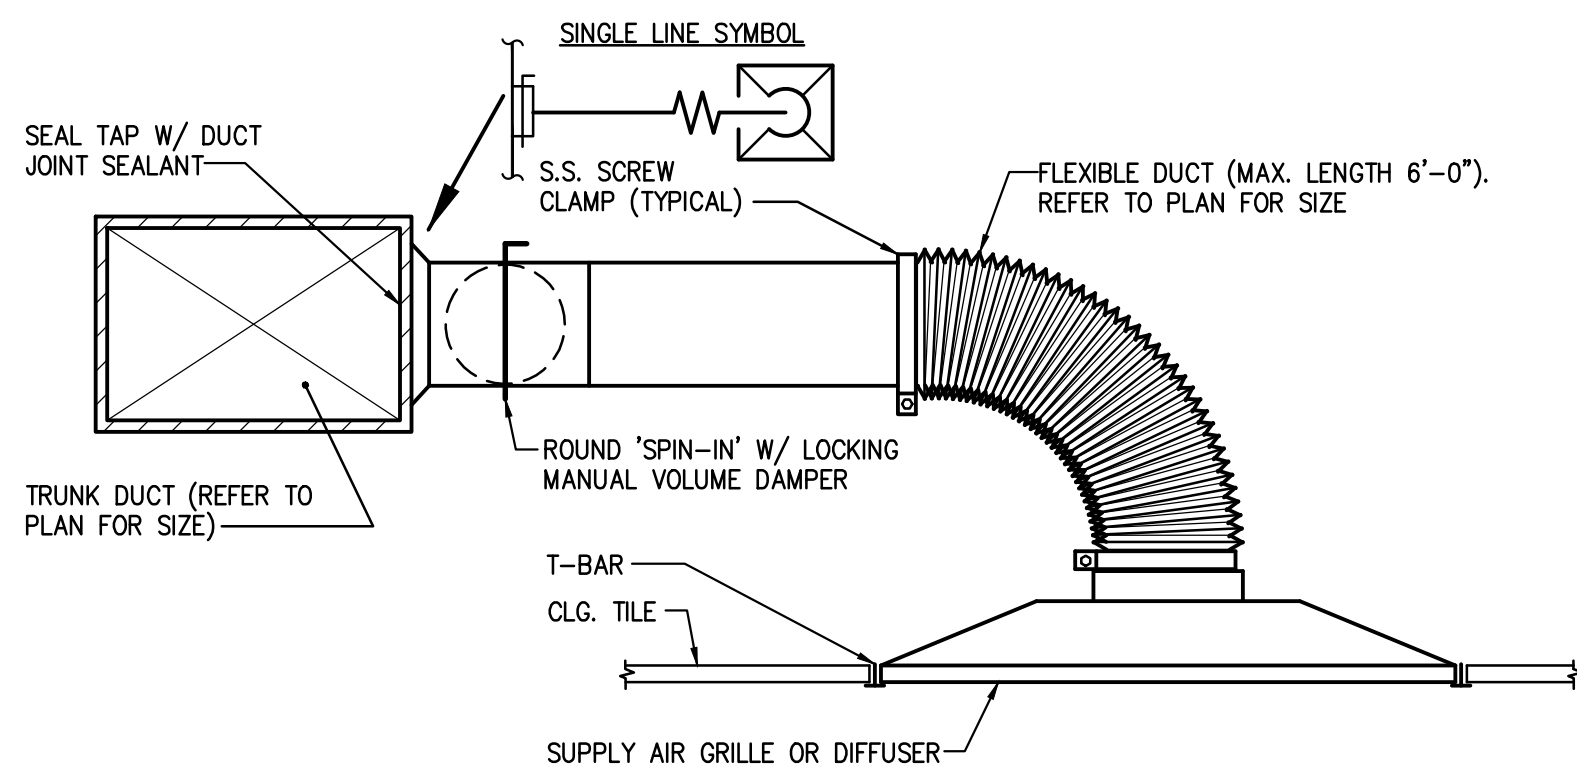

4 SPIN-IN CEILING DIFFUSER DETAIL
SCALE: NONE

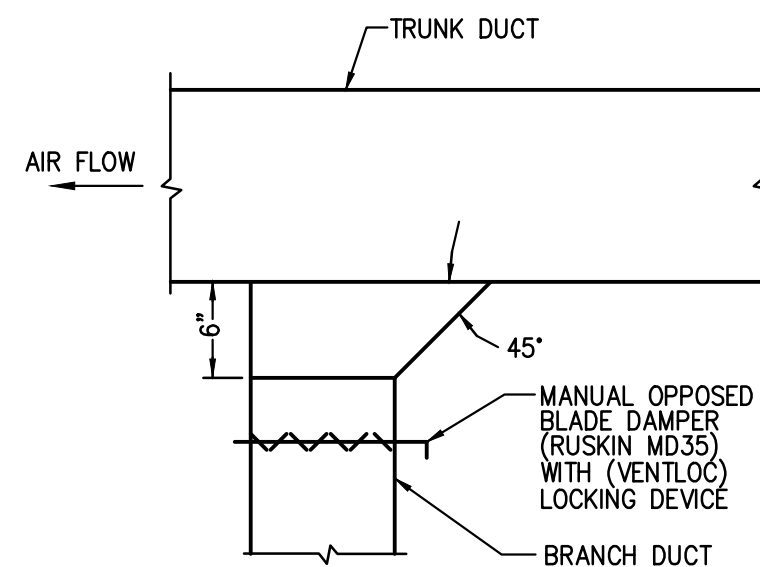

5 BRANCH TAKE OFF DETAIL
SCALE: NONE

Issue Dates:	
FOR LANDLORD REVIEW XX-XX-21	



CFT - MONROE
SLEEP NUMBER

4351 PECANLAND MALL DR.
MONROE, LA 71203

Project Number:	17106-004
Date Plotted:	MAY 20, 2021
Drawn By:	RM
Checked By:	EA
File Name:	CONSTRUCTION DOCUMENTS

M3.0
MECHANICAL DETAILS